



KATERI TEKAKWITHA

HUD #: 023-EE219

NEW CONSTRUCTION OF THIRTY, ONE BEDROOM UNITS
FOR: KATERI TEKAKWITHA HOUSING CORP.
C/O: NORTH AMERICAN MARTYRS CHURCH 8 WYOMA DR. AUBURN, MASS.
KATERI TEKAKWITHA SENIOR HOUSING
HUD SECTION 202 SENIOR HOUSING
8 WYOMA DR. AUBURN, MASS.

**PLUMBING/FIRE
PROTECTION
FIRE PUMP HOUSE
FLOOR PLAN**
SCALE: AS NOTED




DATE: 9/15/09
LEED Δ

SKPFP
2.01A

PROJECT # 2004-1029

6" FIRELINE TO 10'-0" OUTSIDE OF
PUMPHOUSE BY FIRE PROTECTION
CONTRACTOR. CONTINUED TO BUILDING
BY SITE CONTRACTOR. MAINTAIN 6'-0"
MIN COVER. VERIFY EXACT LOCATIONS,
INVERTS AND DETAILS IN FIELD PRIOR
TO ROUGHING.

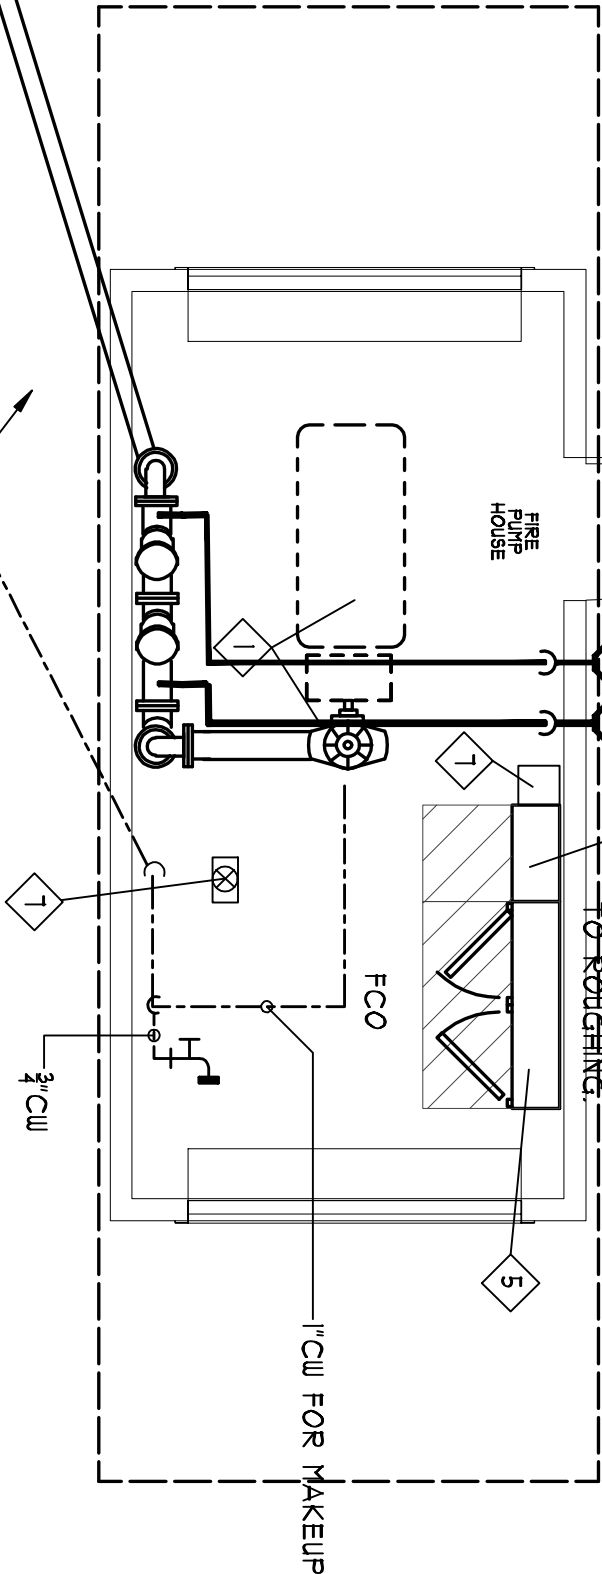

6" FIRELINE TO 10'-0" OUTSIDE OF
PUMPHOUSE BY FIRE PROTECTION
CONTRACTOR. CONTINUED TO BUILDING
BY SITE CONTRACTOR. MAINTAIN 6'-0"
MIN COVER. VERIFY EXACT LOCATIONS,
INVERTS AND DETAILS IN FIELD PRIOR
TO ROUGHING.

PLUMBING/FIRE PROTECTION FIRE PUMP HOUSE FLOOR PLAN

SCALE: 1/4"=1'-0"

NOTES:
1. SEE SYMBOLS, SCHEDULES, NOTES & DETAILS.

PROGRESS PRINT
MARCH 24, 2011
DATE:
NOT FOR CONSTRUCTION

WALTER MCILVEEN
ASSOCIATES, INC.
CONSULTING ENGINEERS
195 WEST MAIN STREET
AVON, CT 06001-0516
WMA 06001-0516

DESIGNED 2011 BY
WALTER MCILVEEN ASSOCIATES, INC.
These documents have been designed specifically for the
project and are not to be used for any other project.
The engineer, design team or architect is not responsible
for the construction of the project or the safety of the
project. The engineer, design team or architect is not
responsible for the safety of the project.